

OFFICE OF THE BOARD OF SELECTMEN

CLARISSA ROWE, CHAIR
JOHN W. HURD, VICE CHAIR
KEVIN GREELEY
DIANE MAHON
ANNIE LACOURT



730 MASSACHUSETTS AVENUE
TELEPHONE
781-316-3020
781-316-3029 FAX

TOWN OF ARLINGTON
MASSACHUSETTS 02476-4908

The License applied for, if Granted, cannot be Sold, Transferred or
Surrendered without the authority of the Board of Selectmen.

PUBLIC ENTERTAINMENT APPLICATION

Fee: \$50.00

8-23-18

Date

To the Board of Selectmen:

The undersigned hereby make application for a
PUBLIC ENTERTAINMENT

Name: Bootsy Mullan

Company: Town Tavern

Address: 201 Mass Ave.

SIGNATURE

RESIDENCE
(Street and Number)

Bootsy Mullan

PRINT NAME

114 Lewis Rd.

SIGNATURE


Bolton MA. 02478

TELEPHONE NUMBER


Country of
birth

USA

PLEASE ATTACH A LAYOUT OF WHERE THE ENTERTAINMENT WILL BE LOCATED ON PREMISE

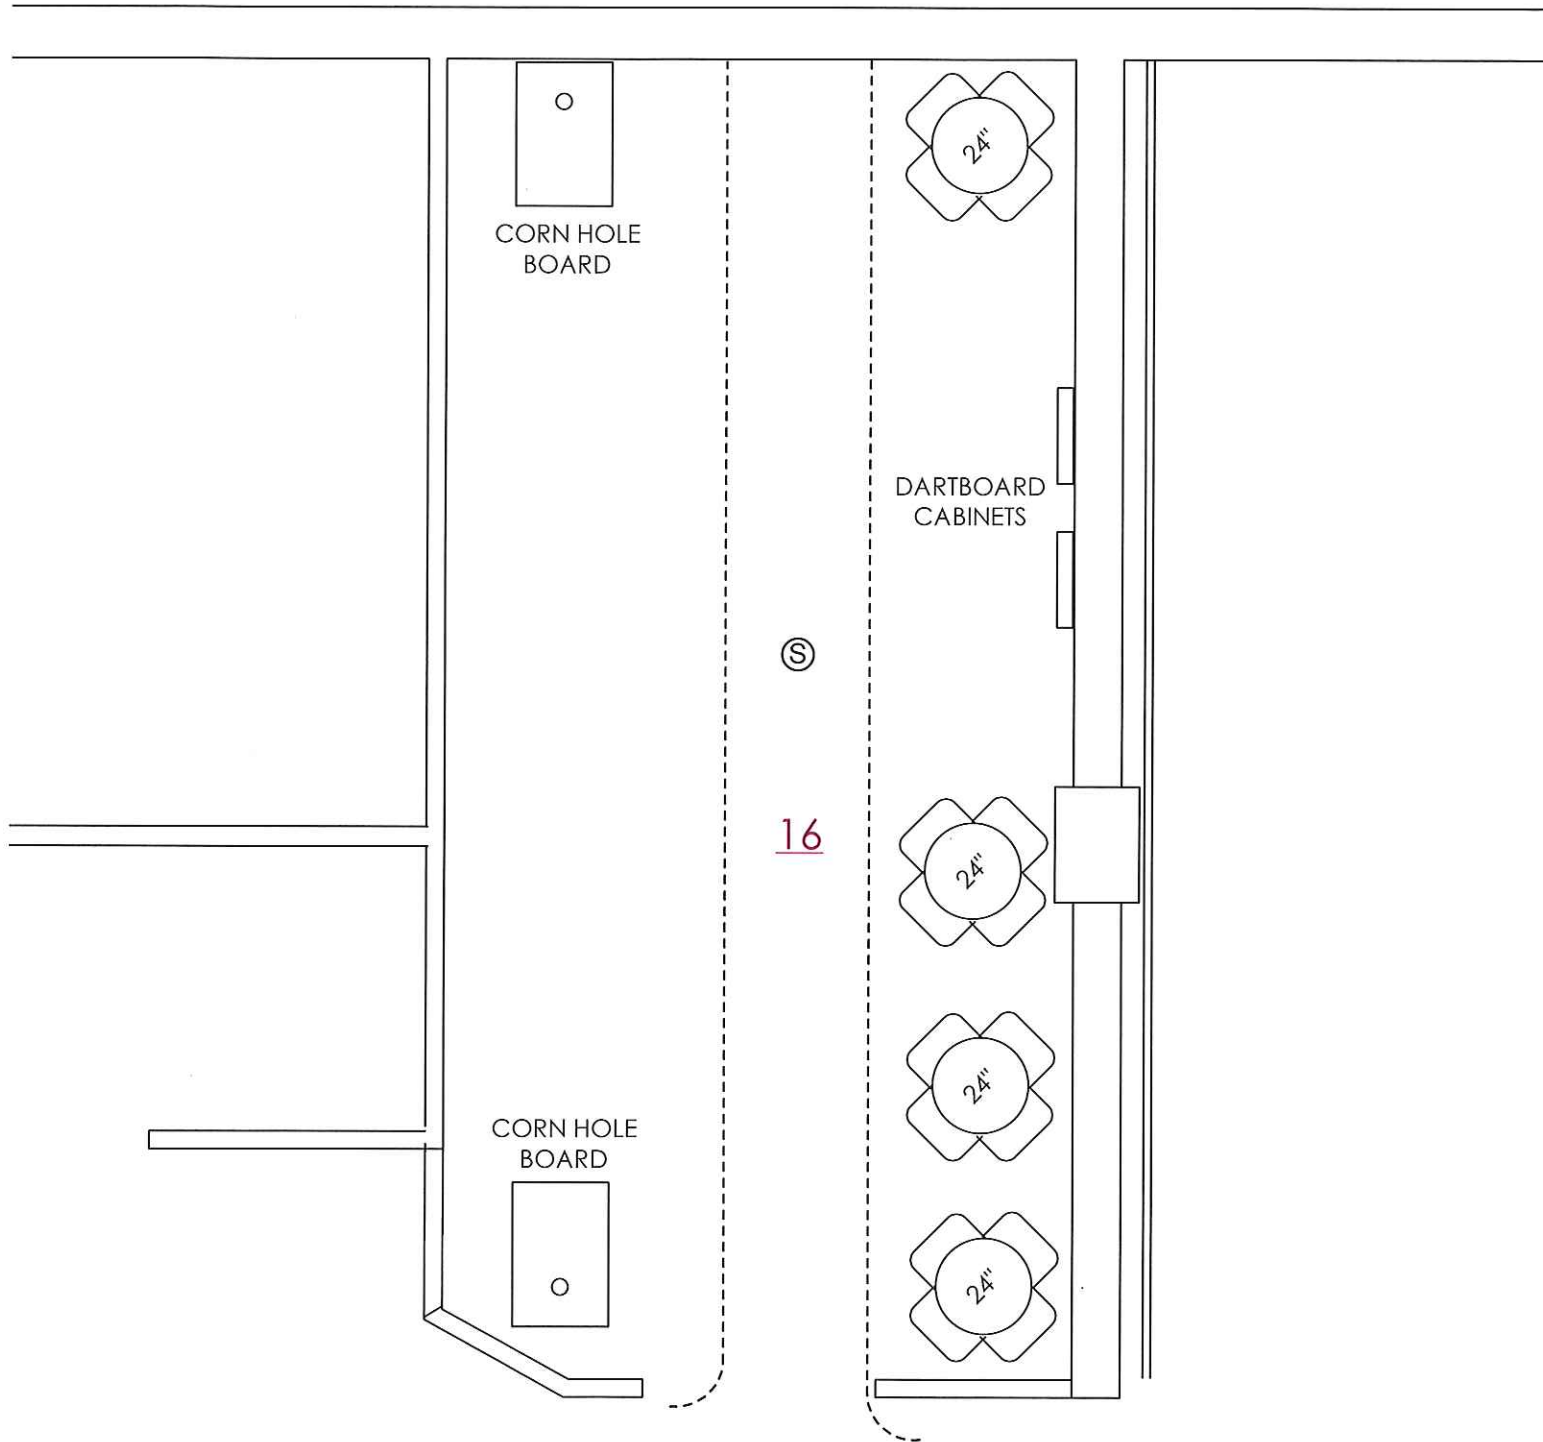

TOWN HALL ROOM
TOWN TAVERN
201 MASS. AVE.
ARLINGTON, MA

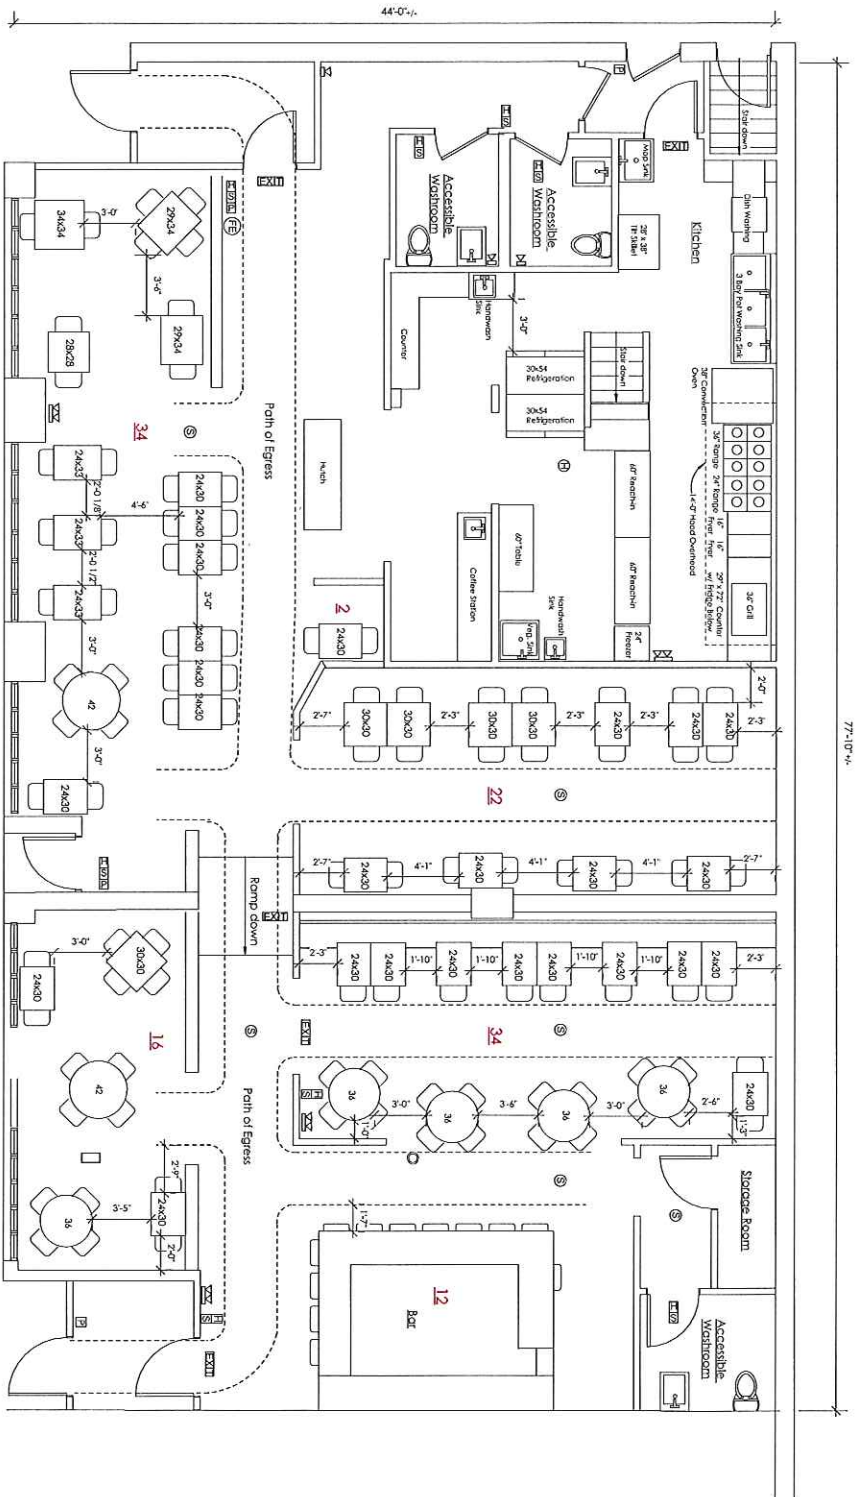

GENERAL CODE INFORMATION

1. USE GROUP: A2d
2. 2,100 APPROXIMATE SQUARE FEET TOTAL DINING AREA ALLOWING 17.5 SQ. FT. PER PERSON
3. 120 PATRONS AND 14 RESTAURANT STAFF. BASEMENT OCCASIONAL LOAD OF 1 OCCUPANT
4. 2 TOILETS AND 2 SINKS PER 60 WOMEN; 1 TOILET AND 1 SINK PER 60 MEN
5. 2 REQUIRED MINIMUM NUMBER OF EXITS FOR OCCUPANT LOAD WITH EXIT SIGNS.
6. COMBUSTIBLE UNPROTECTED TYPE SB CONSTRUCTION
7. ADEQUATE SMOKE AND CO DETECTORS TO BE INSTALLED AS PER THE DIRECTIVE OF THE TOWN OF ARLINGTON FIRE MARSHAL.
8. NO FIRE SUPPRESSION IN PLACE

KEY

- PULL STATION
- Ⓜ HORN/STROBE
- Ⓜ HORN/STROBE/PULL STATION
- Ⓜ ILLUMINATED EXIT SIGN
- Ⓜ EMERGENCY LIGHTING
- Ⓜ SMOKE DETECTOR
- Ⓜ HEAT DETECTOR
- Ⓜ FIRE EXTINGUISHER

PROJECT NORTH E N S W	DATE: MAY 8th 2018	TITLE: SEATING AND FIRE PROTECTION PLAN	PROJECT: TOWN TAVERN 201 MASSACHUSETTS AVE. ARLINGTON, MA 02474	CLIENT: GEORGE MULLAN 114 LEWIS ROAD BELMONT, MA 02478 617-719-3700	MARTHA PENZENIK ARCHITECTS 635 MASSACHUSETTS AVENUE ARLINGTON, MA 02476 Tel: 781-463-1313 mcp@marthapenzetik.com	REGISTERED ARCHITECT MARIA A. PENZENIK ARLINGTON, MA MASSACHUSETTS
SCALE: 3/16" = 1'-0"	REVISIONS:					