



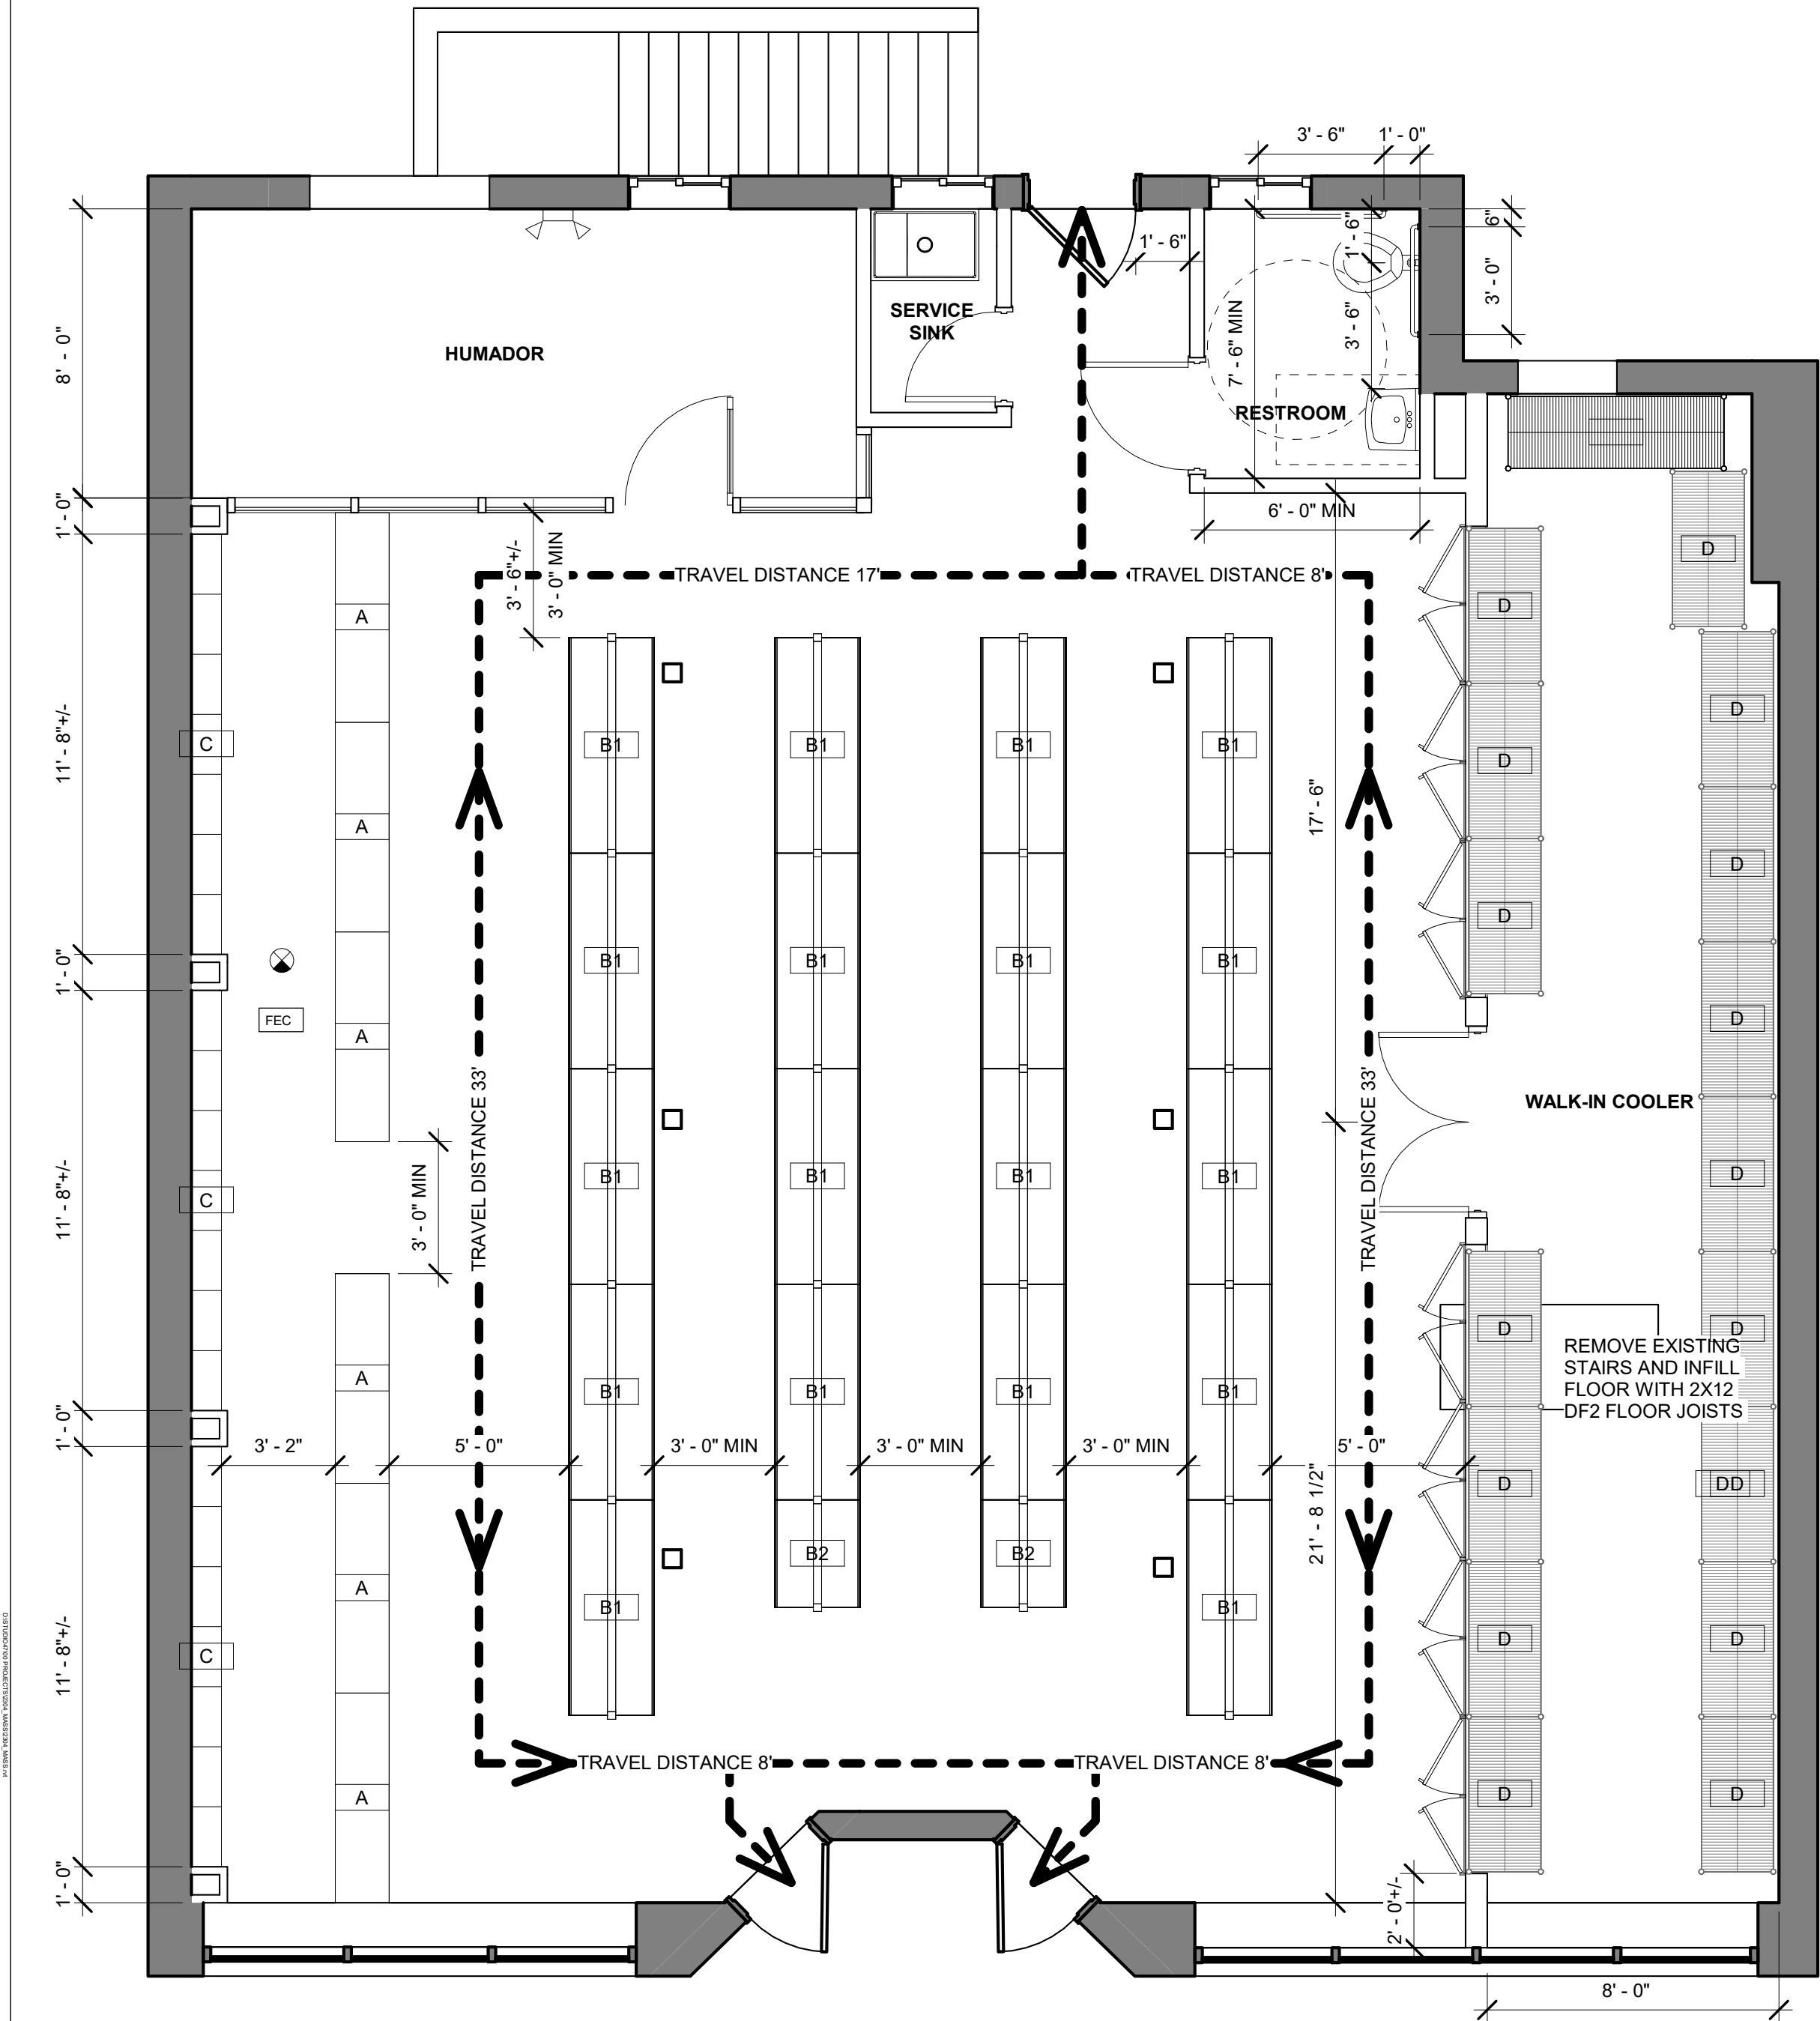

1 FLOOR PLAN
1/4" = 1'-0"

DISPLAY EQUIPMENT SCHEDULE		
MARK	DESCRIPTION	COUNT
A	GLASS DISPLAY CASE 70"	6
B1	SLATWALL H GONDOLA 72"	18
B2	SLATWALL H GONDOLA 36"	2
C	SLATWALL W/ SHELIVING	3
D	COMMERCIAL WIRE SHELIVING 48"	16

LIGHTING FIXTURE SCHEDULE		
MARK	Description	Count
A	RECESSED TROFFER	23
B	T8 MINI STRIP - 48"	7
D1	WALL MOUNT EGRESS LIGHTING (INTERIOR)	8
D2	WALL MOUNT EGRESS LIGHTING (EXTERIOR)	1
E	ILLUMUNATED EXIT SIGN	8

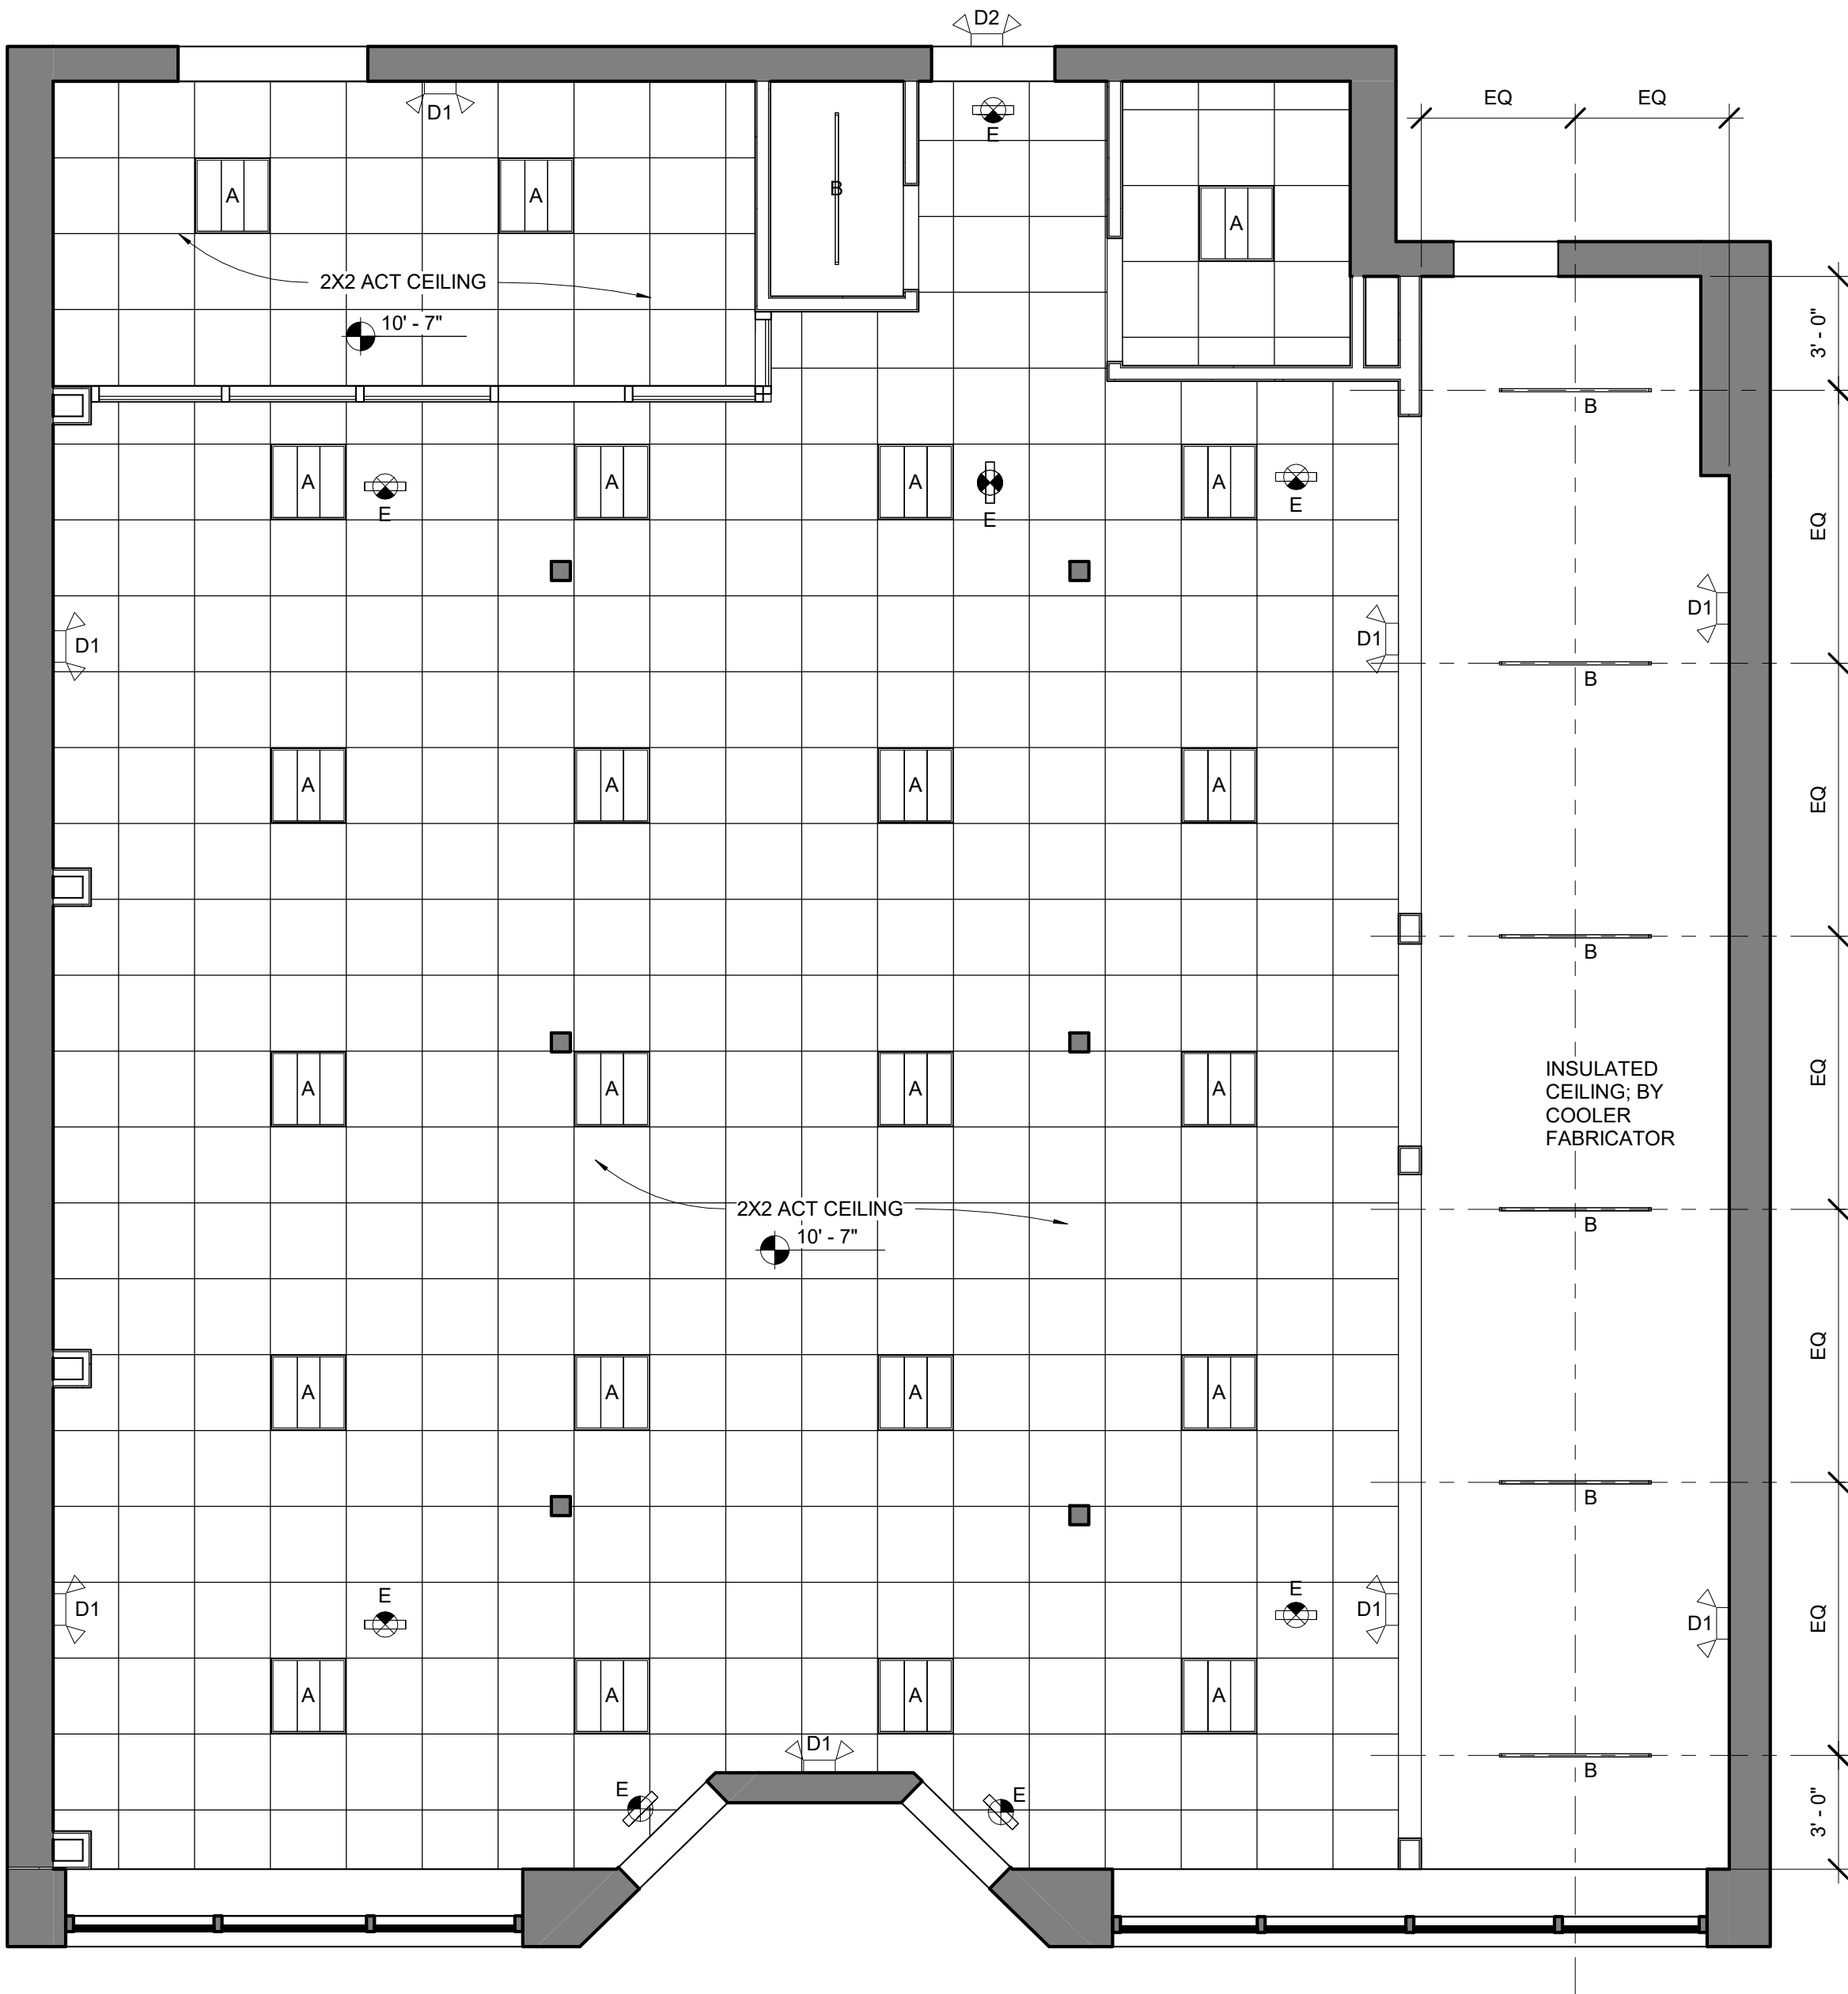

2 REFLECTED CEILING PLAN
1/4" = 1'-0"

PROJECT:
SMOKE SHOP
RETAIL FIT-UP

232-234
Massachusetts Ave
Arlington, MA 02474

CLIENT:
Nilesh Pital
618 Massachusetts Ave
Cambridge, MA 02140

PROJECT TEAM:

REVISIONS:

DRAWING TITLE:

FLOOR
PLANS

STAMP

February 28, 2023
DATE OF ISSUE

PERMITTING
DOCUMENT PHASE

1/4" = 1'-0"
SCALE

2304.00
PROJECT #

DRAWING NUMBER:

A100